

PROJECT CONTACTS

PROJECT DIRECTOR
BRADLEY FITE, SUNENERGY1

PROJECT MANAGER
DIRK CORN, SUNENERGY1

PROJECT ENGINEERING
KEITH HARDT, PE
PUNGO ENGINEERING

PROJECT DESIGN
DUSTIN SMITH, SUNENERGY1

VICINITY MAP



SITE INFORMATION

COUNTY - HERTFORD
WIND SPEED = 100 MPH
SNOW LOAD = 10 PSF


ASHRAE WEATHER STATION: GREENVILLE, NC
MINIMUM MEAN EXTREME DRY BULB TEMP = -10°C
2% AVERAGE HIGH TEMP = 35°C

PROJECT TITLE

AULANDER HOLLOMAN
SOLAR, LLC

99.9 MEGAWATT AC PHOTOVOLTAIC
GROUND MOUNTED POWER PLANT
IN AULANDER, NORTH CAROLINA

SITE MAP

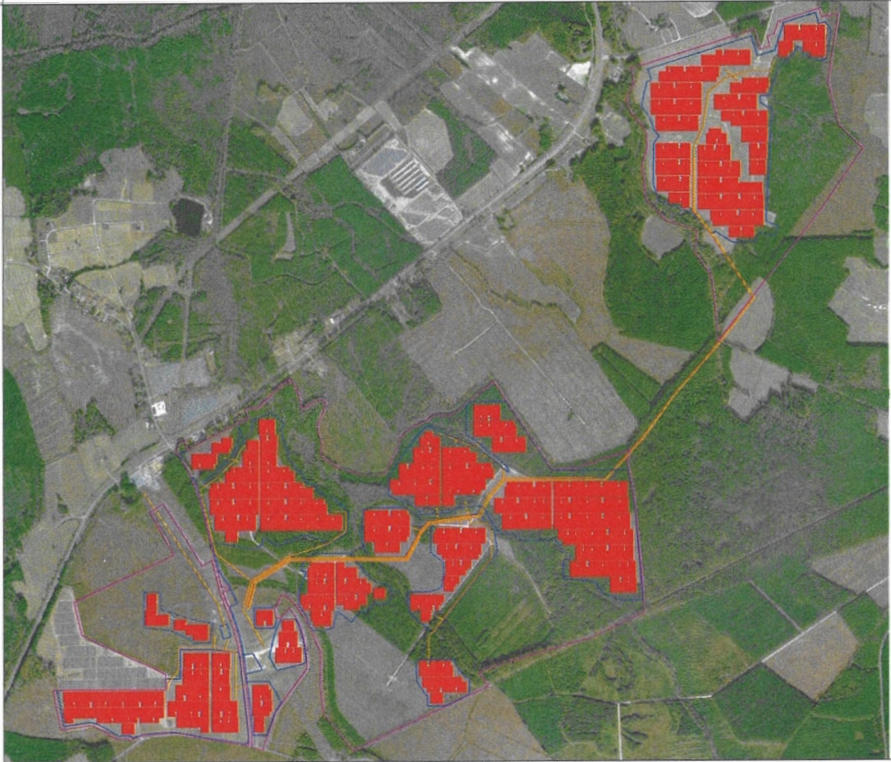

SITE ADDRESS

111 EAST BRICKMILL RD.
AULANDER, NC 27805

INDEX OF DRAWINGS

SEE G1.1 FOR DRAWING LIST

COVER SHEET

G1.0

CPCN APPLICATION SCHEDULE 4
SITE LAYOUT
SP-5259 SUB 0



192 Raceway Dr.
Mooresville, NC 28117
(T) 704-662-0375
(F) 704-662-0352

NO.	DATE	DESCRIPTION
1	2/23/15	RELEASED FOR PERMIT
2	6/15/15	RELEASED FOR ZONING PERMIT
3	12/15/15	UPDATED FOR WETLANDS
4	4/23/16	RELEASED FOR PERMIT
5	5/15/16	ADDED FENCE FOUNDING AND HELP-PODUNK ELECTRICAL DRAWINGS
6	5/15/16	ADDED TOPOGRAPHY SHEET
7	5/15/17	EXHIBIT
8	5/15/17	WETLAND EXHIBIT
9	12/17/17	FINAL WETLAND DELINEATION
10	4/20/18	15%WQEC LAYOUT
11	5/15/18	PHASE 1 PERMIT SET
12	10/15/18	PHASE 2 PERMIT SET
13	11/15/17	AS BUILT PACKAGE
14	10/15/17	PDS DRAWING SET UPDATE

CHECKED

DS

CJM

PROJECT NAME

AULANDER HOLLOMAN
SOLAR, LLC

PV POWER PLANT
IN AULANDER, NORTH CAROLINA

DATE ORIGINAL
04 FEB 15

LATEST REVISION
10 JUNE 2021


JOB NO.
AA1-065

NTS

OFFICIAL COPY

Oct 27 2023

IN SCHEDULE 4
SITE LAYOUT
SP-5259 SUB 0

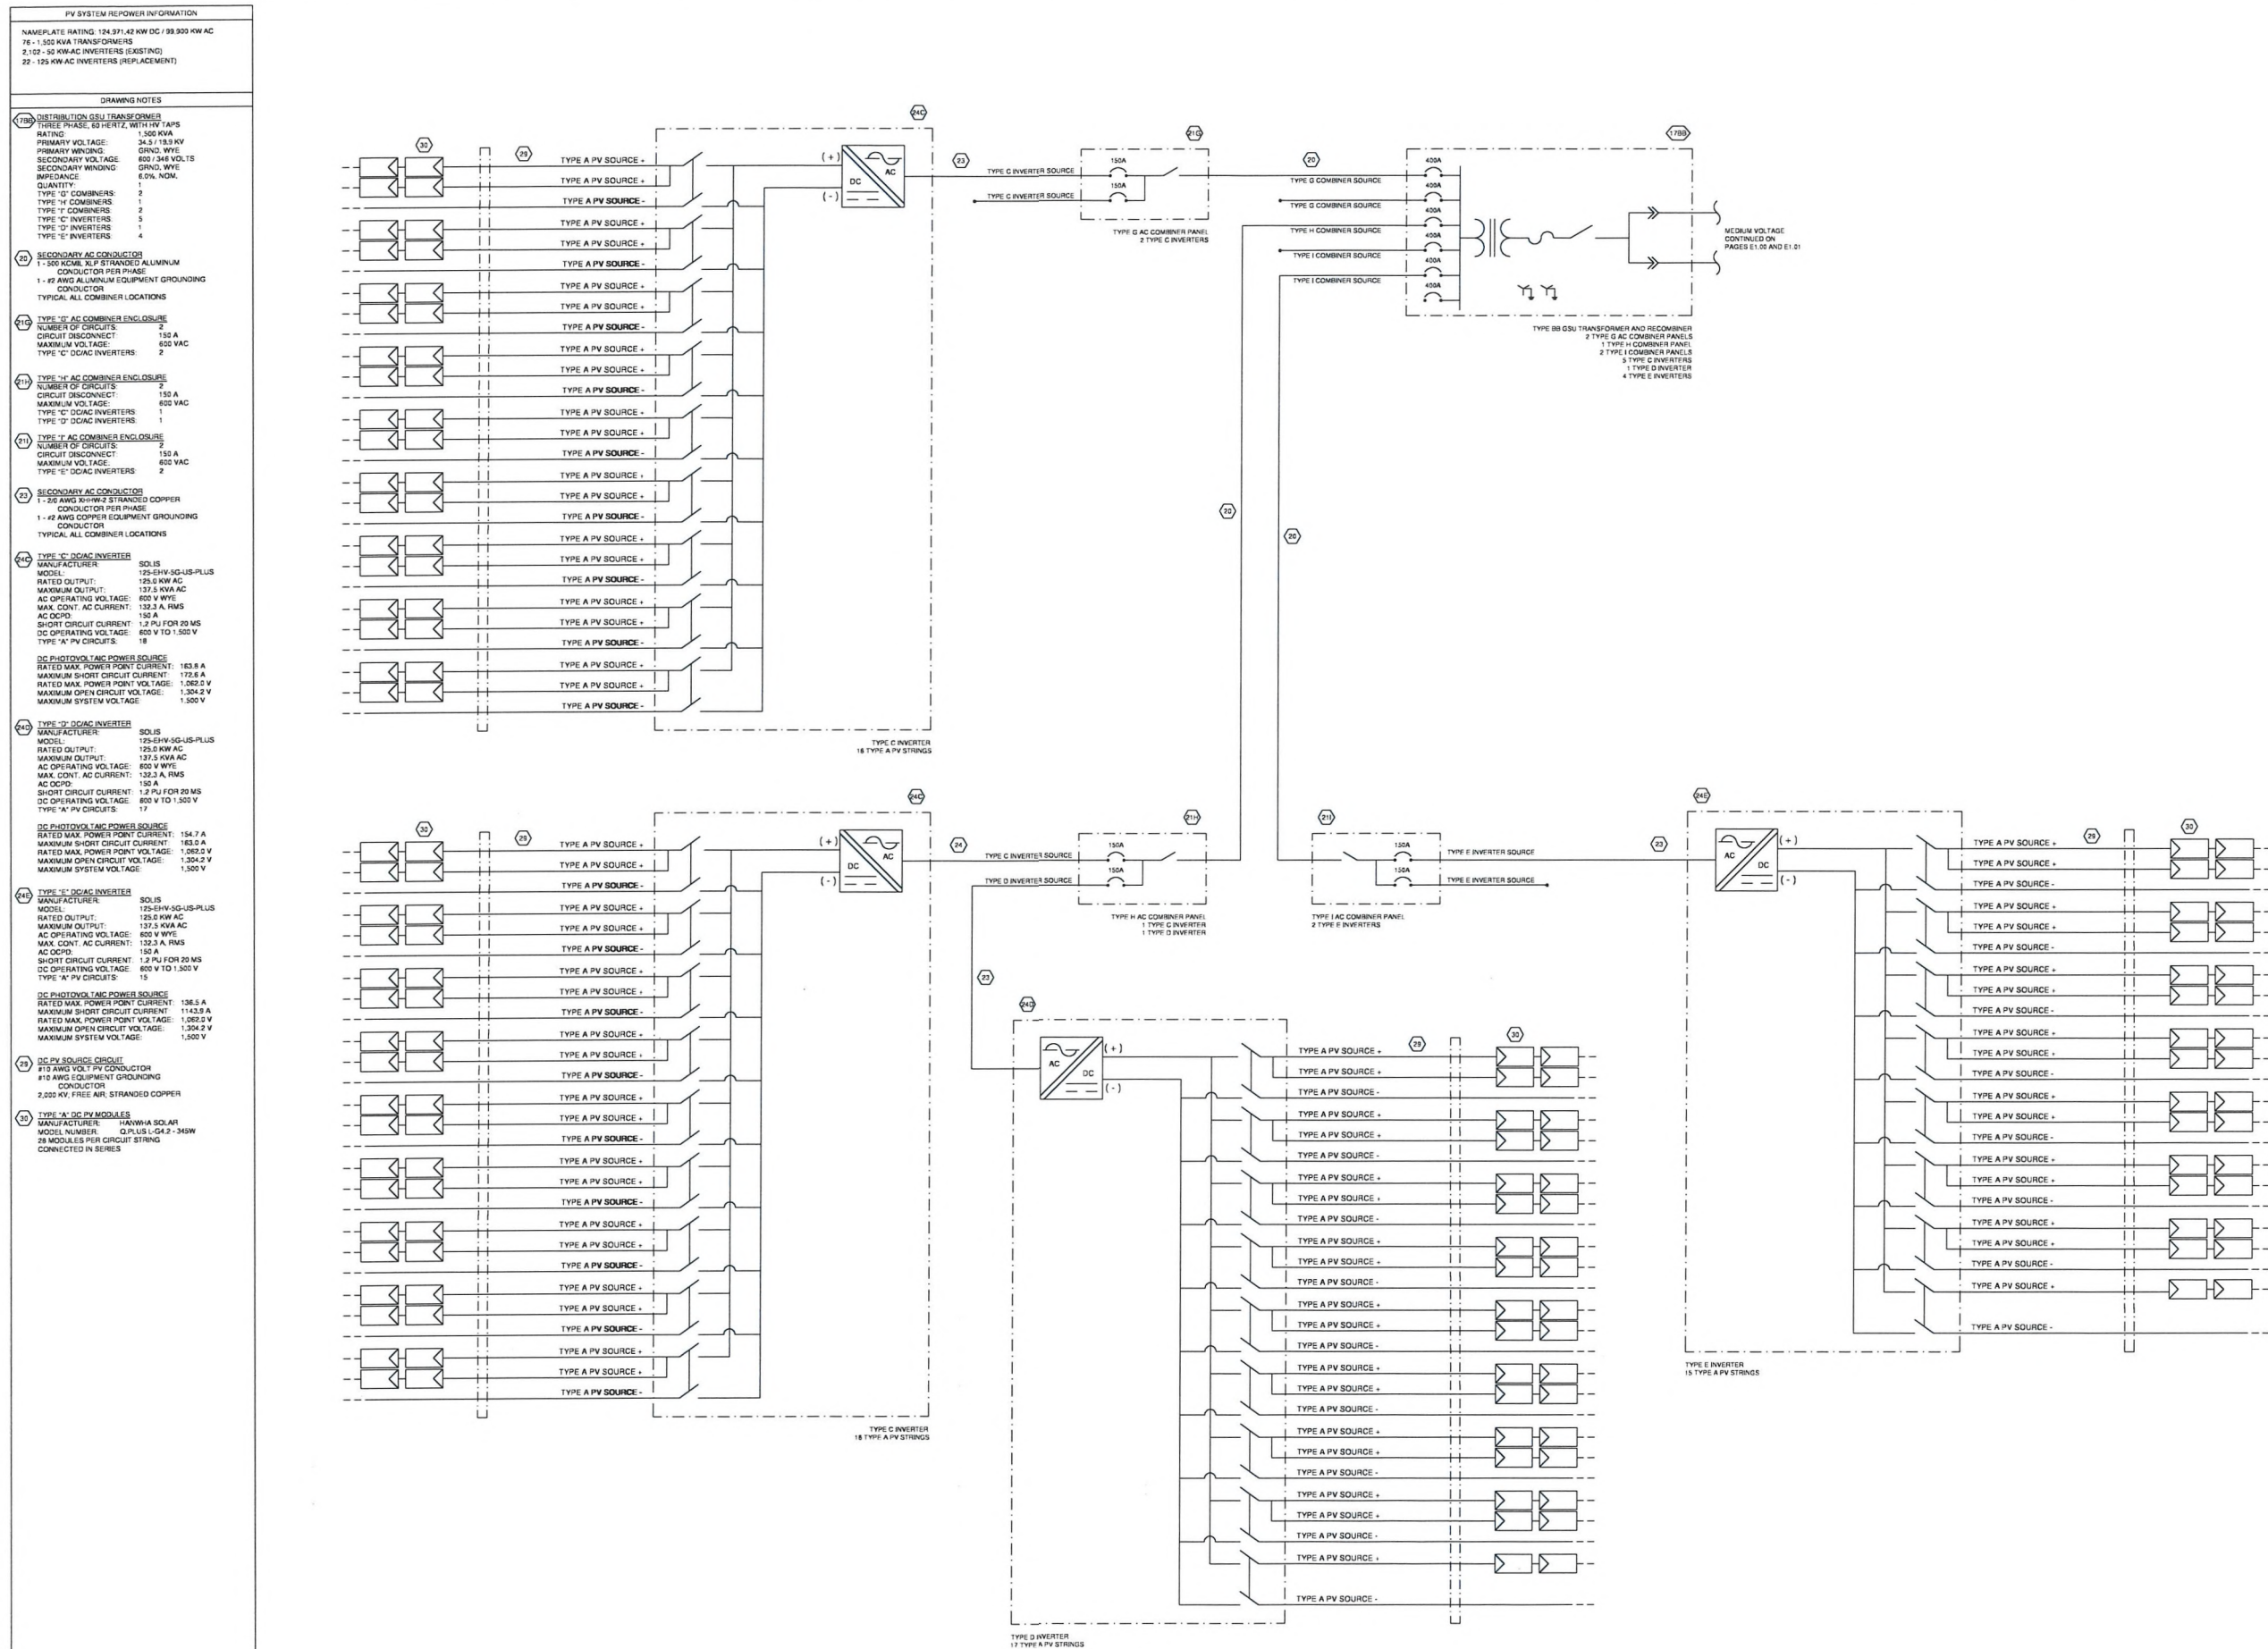

TRANSFORMER T10 REPOWER PLAN

PUNGO
ENGINEERING
SERVICES

PUNGO ENGINEERING SERVICES, PLLC
NORTH CAROLINA LICENSE #1265
424 EAST MAIN STREET
WASHINGTON, NORTH CAROLINA 27789
INFO@PUNGOENGINEERING.COM
(321) 945-8652



192 RACEWAY DR.
MOORESVILLE, NC 28117

(T) 704-662-0375
(F) 704-662-0352

ELECTRIC UTILITY - NORTH CAROLINA POWER / PJM INTERCONNECT
UTILITY VOLTAGE - 230 KV

NO.	DATE	DESCRIPTION
9	8/7/79	TRAVEL EXPENSE - GENEVA, S.W.

PJM AAI-065

05.14143


17 MARCH 2023

DRAWING NUMBER

E4.03

OFFICIAL COPY

Oct 27 2023

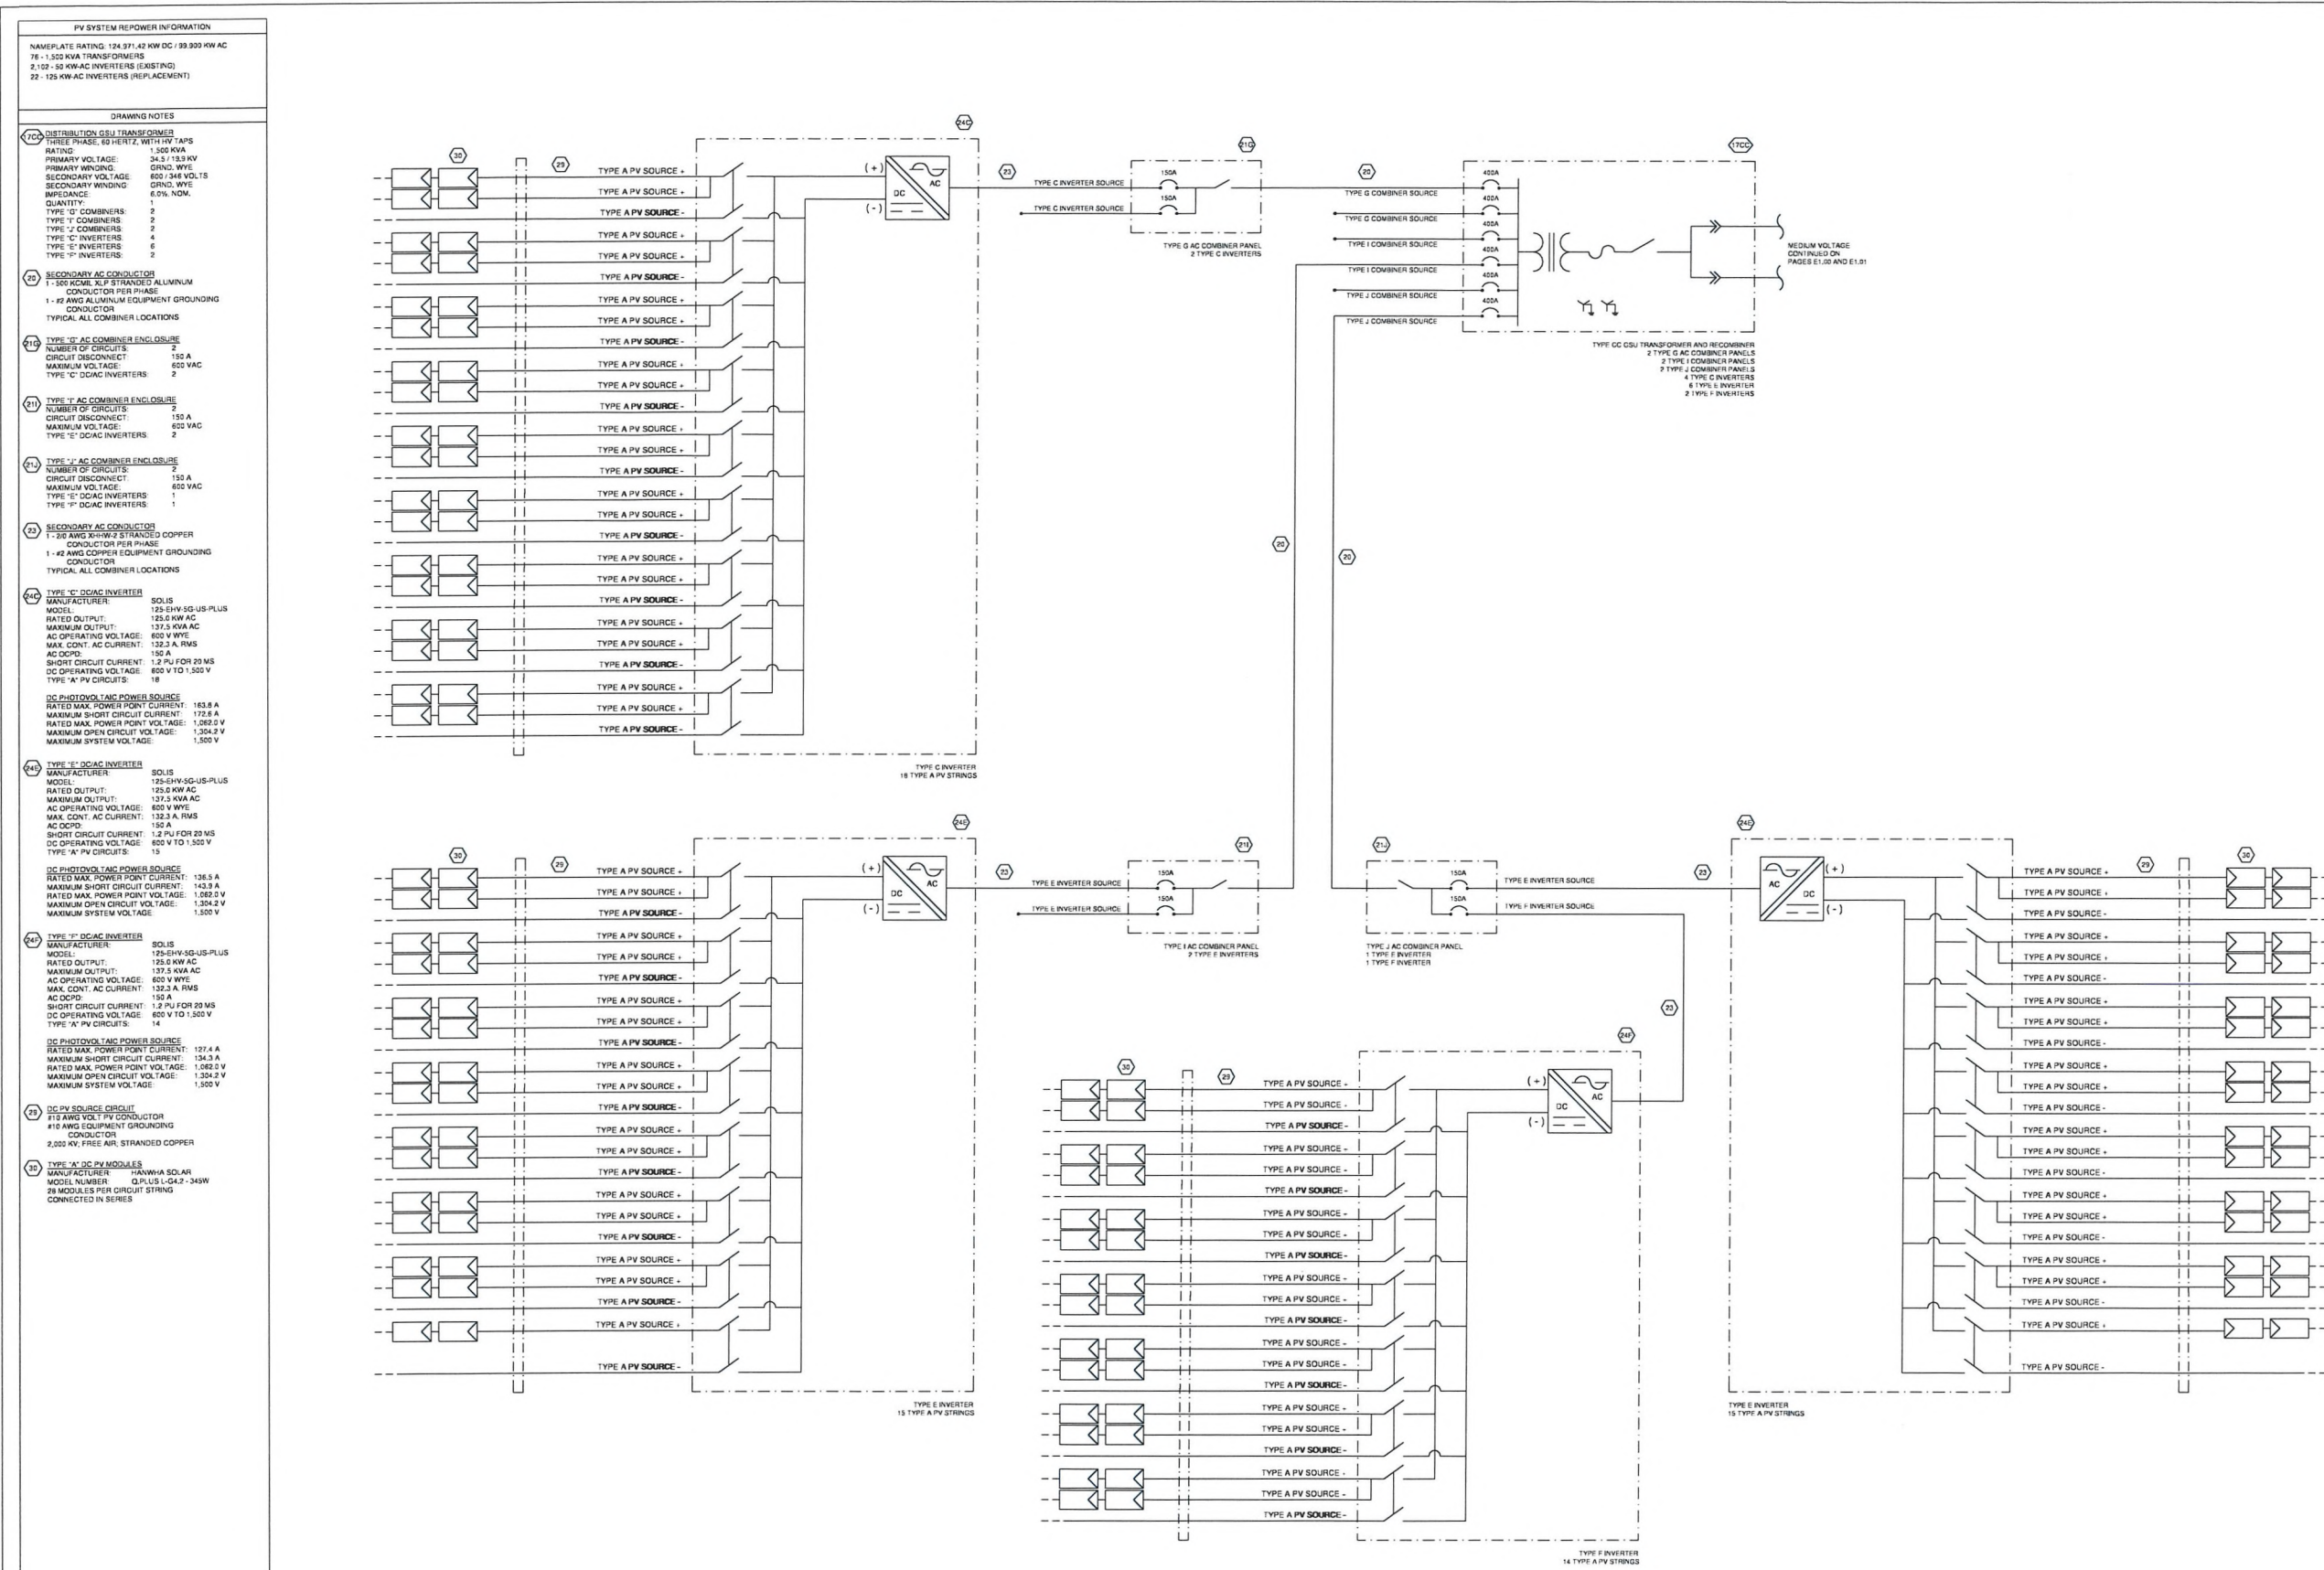

TRANSFORMER T11 REPOWER PLAN

[illegible]